


MPA 2023

13-14 OCTOBER 2023

KUALA LUMPUR CONVENTION CENTRE KLCC, CONFERENCE HALL 2

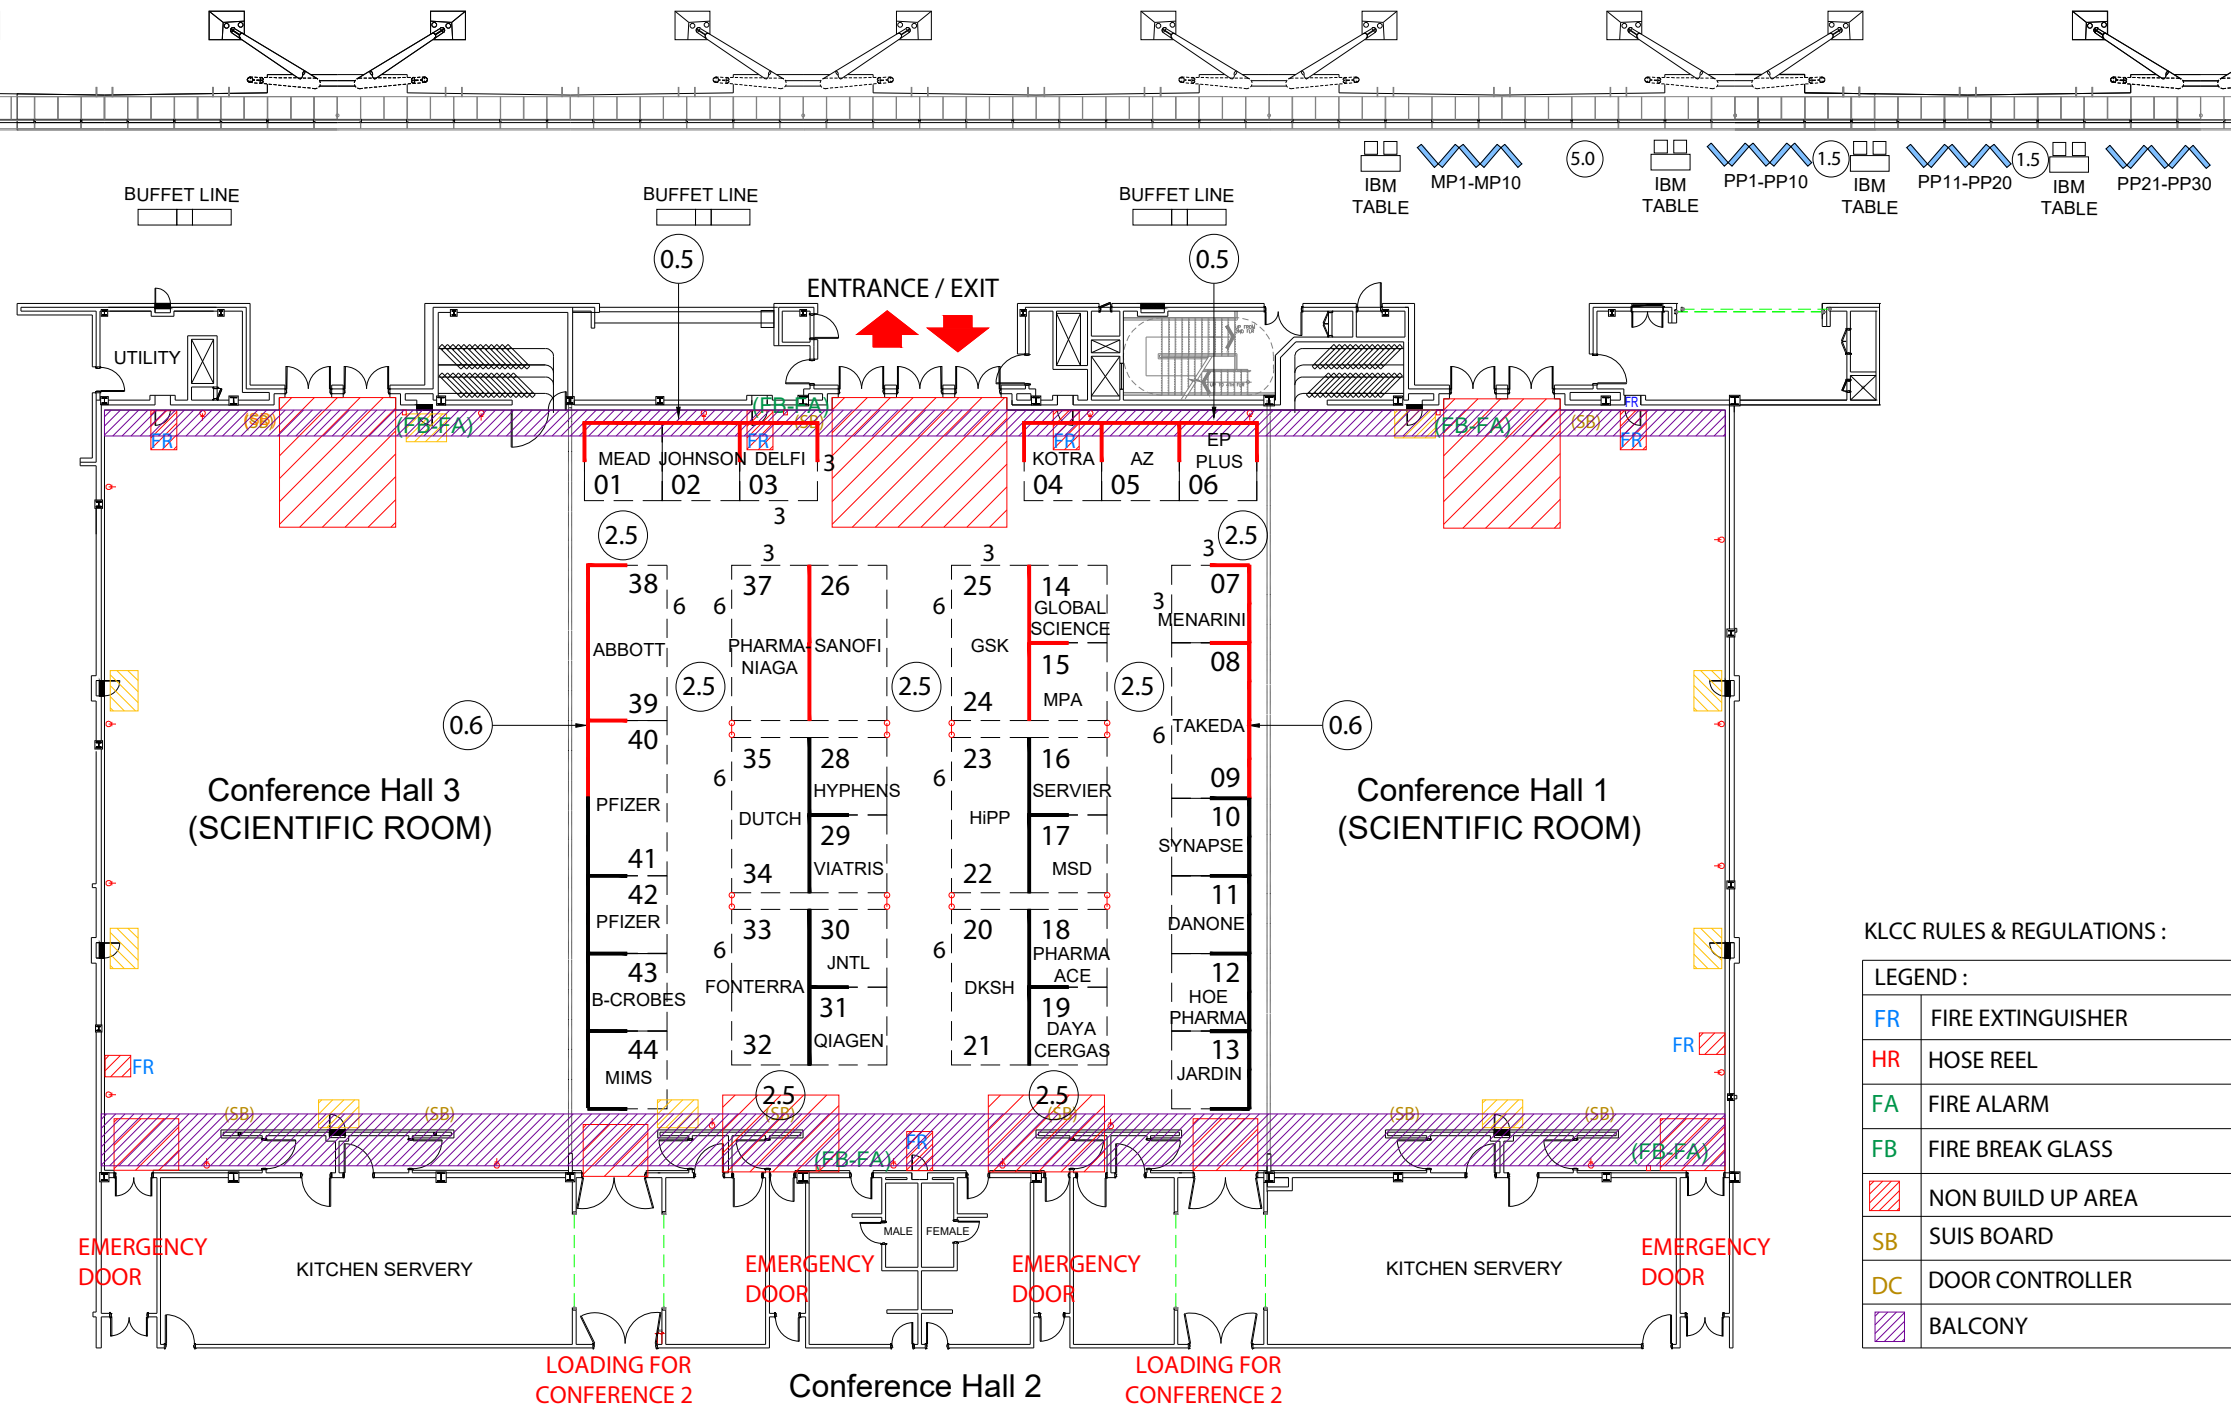

KLCC RULES & REGULATIONS :

LEGEND :	
FR	FIRE EXTINGUISHER
HR	HOSE REEL
FA	FIRE ALARM
FB	FIRE BREAK GLASS
(diagonal lines)	NON BUILD UP AREA
SB	SUIS BOARD
DC	DOOR CONTROLLER
(hatched)	BALCONY

* THIS FLOOR PLAN IS SUBJECT TO KUALA LUMPUR CONVENTION CENTRE APPROVAL

PROJECT / EXHIBITION / SHOW MPA 2023	SHOW PERIOD 13-14 OCTOBER 2023	CLIENT EVENT SOLUTION		PERSON-IN-CHARGE -	REMARKS -	AMENDMENT	DATE	DRAWING TITLE
VENUE / ADDRESS KUALA LUMPUR CONVENTION CENTRE CONFERENCE HALL 2				SCALE - DRAWN BY DATE AZ 22.12.2022 CHECKED BY DATE AZIZ 17.05.2022		R14	06.09.2023	LAYOUT PLAN
						R15	07.09.2023	
CITY / COUNTRY MALAYSIA				CLIENT APPROVED DATE - -		R16	12.09.2023	
						R10	24.05.2023	
						R11	25.05.2023	
						R12	08.06.2023	
This design is copyright of Pico International (M) Sdn Bhd which cannot be reproduced or modified. Any unauthorised use in part or in whole is subject to prosecution. This drawing is subject to modification to suit construction purposes						R13	28.07.2023	DRAWING NUMBER EPA/001-OA-R16